

**I MAIN LOBBY FLOOR PLAN**  
 SCALE: 0 5' 10' 20'

**USA**  
 ARCHITECTS  
 PLANNERS  
 + INTERIOR  
 DESIGNERS


20 North Doughty Ave  
 Somerville New Jersey  
 0 8 8 7 6  
 P 722.2300.fax  
 F 722.7201.fax


75 Park Hill Blvd.  
 Easton Pennsylvania  
 1 8 0 4 2  
 P 610.556.0000.fax  
 F 610.556.2174.fax



**ADDITION AND ALTERATIONS**  
 AT  
**THE UNIVERSITY HOSPITAL LOBBY**  
 FOR THE  
**UNIVERSITY OF MEDICINE AND DENTISTRY**  
 OF NEW JERSEY  
 150 BERGEN STREET  
 NEWARK, NEW JERSEY 07103 2406

Drawing Title	
<b>MAIN LOBBY FLOOR PLAN</b>	
Scale	Project No.
AS SHOWN	2004-005
Datum Elev.	NA
Dwg. Date	Drawing No.
4/29/04	<b>5.1</b>
Drawn By	Sheet No. of
CHAW	1 of 4
Chkd. By	
JH	

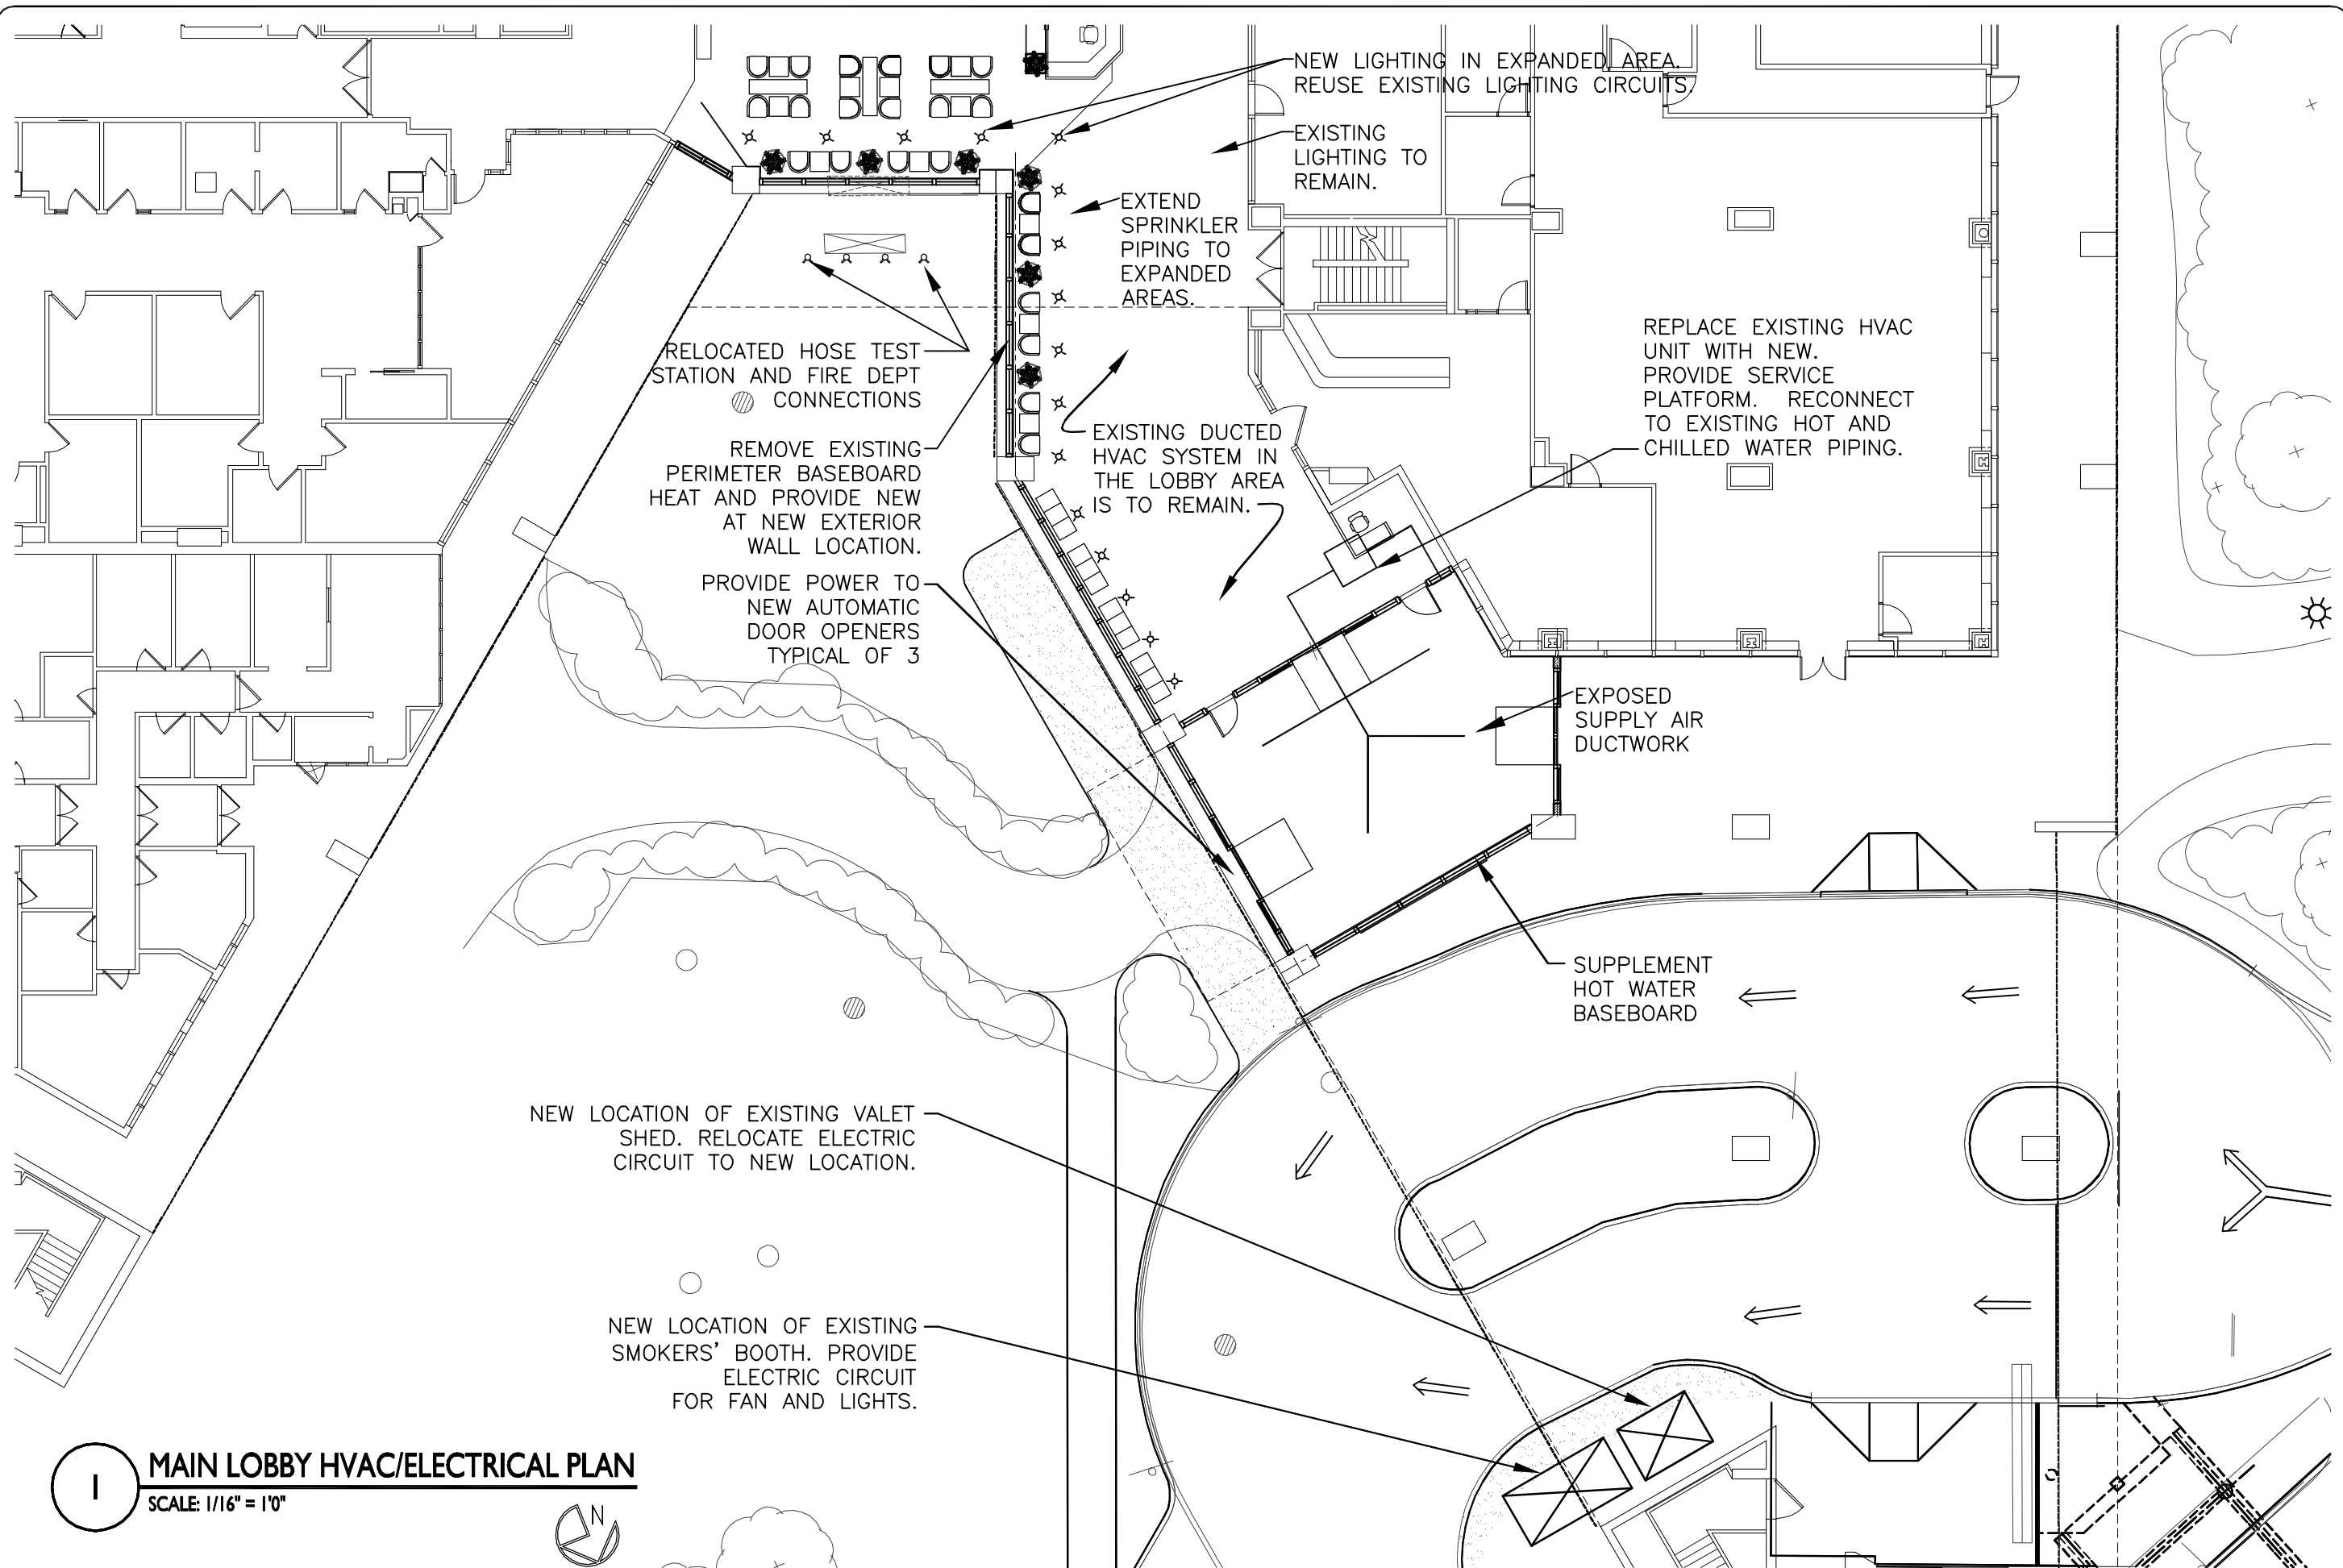

**I** **MAIN LOBBY HVAC/ELECTRICAL PLAN**  
 SCALE: 1/16" = 1'0"  


**USA**  
 ARCHITECTS  
 PLANNERS  
 + INTERIOR  
 DESIGNERS

20 North Doughty Ave  
 Somerville New Jersey  
 0 8 8 7 6  
 P 722.2300.fax  
 F 722.7201.fax

70 Park Ridge Blvd  
 Easton Pennsylvania  
 1 8 0 4 2  
 P 610.566.0000.fax  
 F 610.566.2174.fax



**ADDITION AND ALTERATIONS**  
 AT  
**THE UNIVERSITY HOSPITAL LOBBY**  
 FOR THE  
**UNIVERSITY OF MEDICINE AND DENTISTRY**  
**OF NEW JERSEY**  
 150 BERGEN STREET  
 NEWARK, NEW JERSEY 07103 2406

Drawing Title	
<b>MAIN LOBBY HVAC/ELECTRICAL PLAN</b>	
Scale	Project No.
AS SHOWN	2004-005
Datum Elev.	
N/A	
Dwg. Date	Drawing No.
4/29/04	<b>5.3</b>
Drawn By	
CHAW	
Chkd. By	Sheet No. of
JH	3 of 4